



The Aanwijzing Result of RFQ NO: K19453

Day / Date: Friday, August 28, 2026.

Time: 10.00 WIB – Finish.

Venue: Zoom

Administration:


Before: • Delivery time: not later than November 02, 2026.	After: • Delivery time: not later than 90 calendar days after PO effective date.
--	--

Technical:


Before:	After: • Please see attachment the detail drawing.
---------	--

Note:


- Closing date of bidding document submission: not later than 11.00 WIB date September 08, 2026 at 2nd gate of PT. KPJB's security.
- The quotation shall be submitted in one sealed envelope containing both the priced and unpriced proposals.
- Payment will be made by Telegraphic Transfer (T/T) fortyfive (45) days after invoice received, attached with delivery or work completion report issued by PT.KPJB.
- The others clauses, terms and conditions of this RFQ that not speicified in this MOM of aanwijzing and not against this MOM of aanwijzing still remains unchanged.
- Duty stamp for quotation should follow the new Government's regulation (duty stamp 10.000).
- KPJB safety rules and GTC as attached.
- Term of Refference as attached.

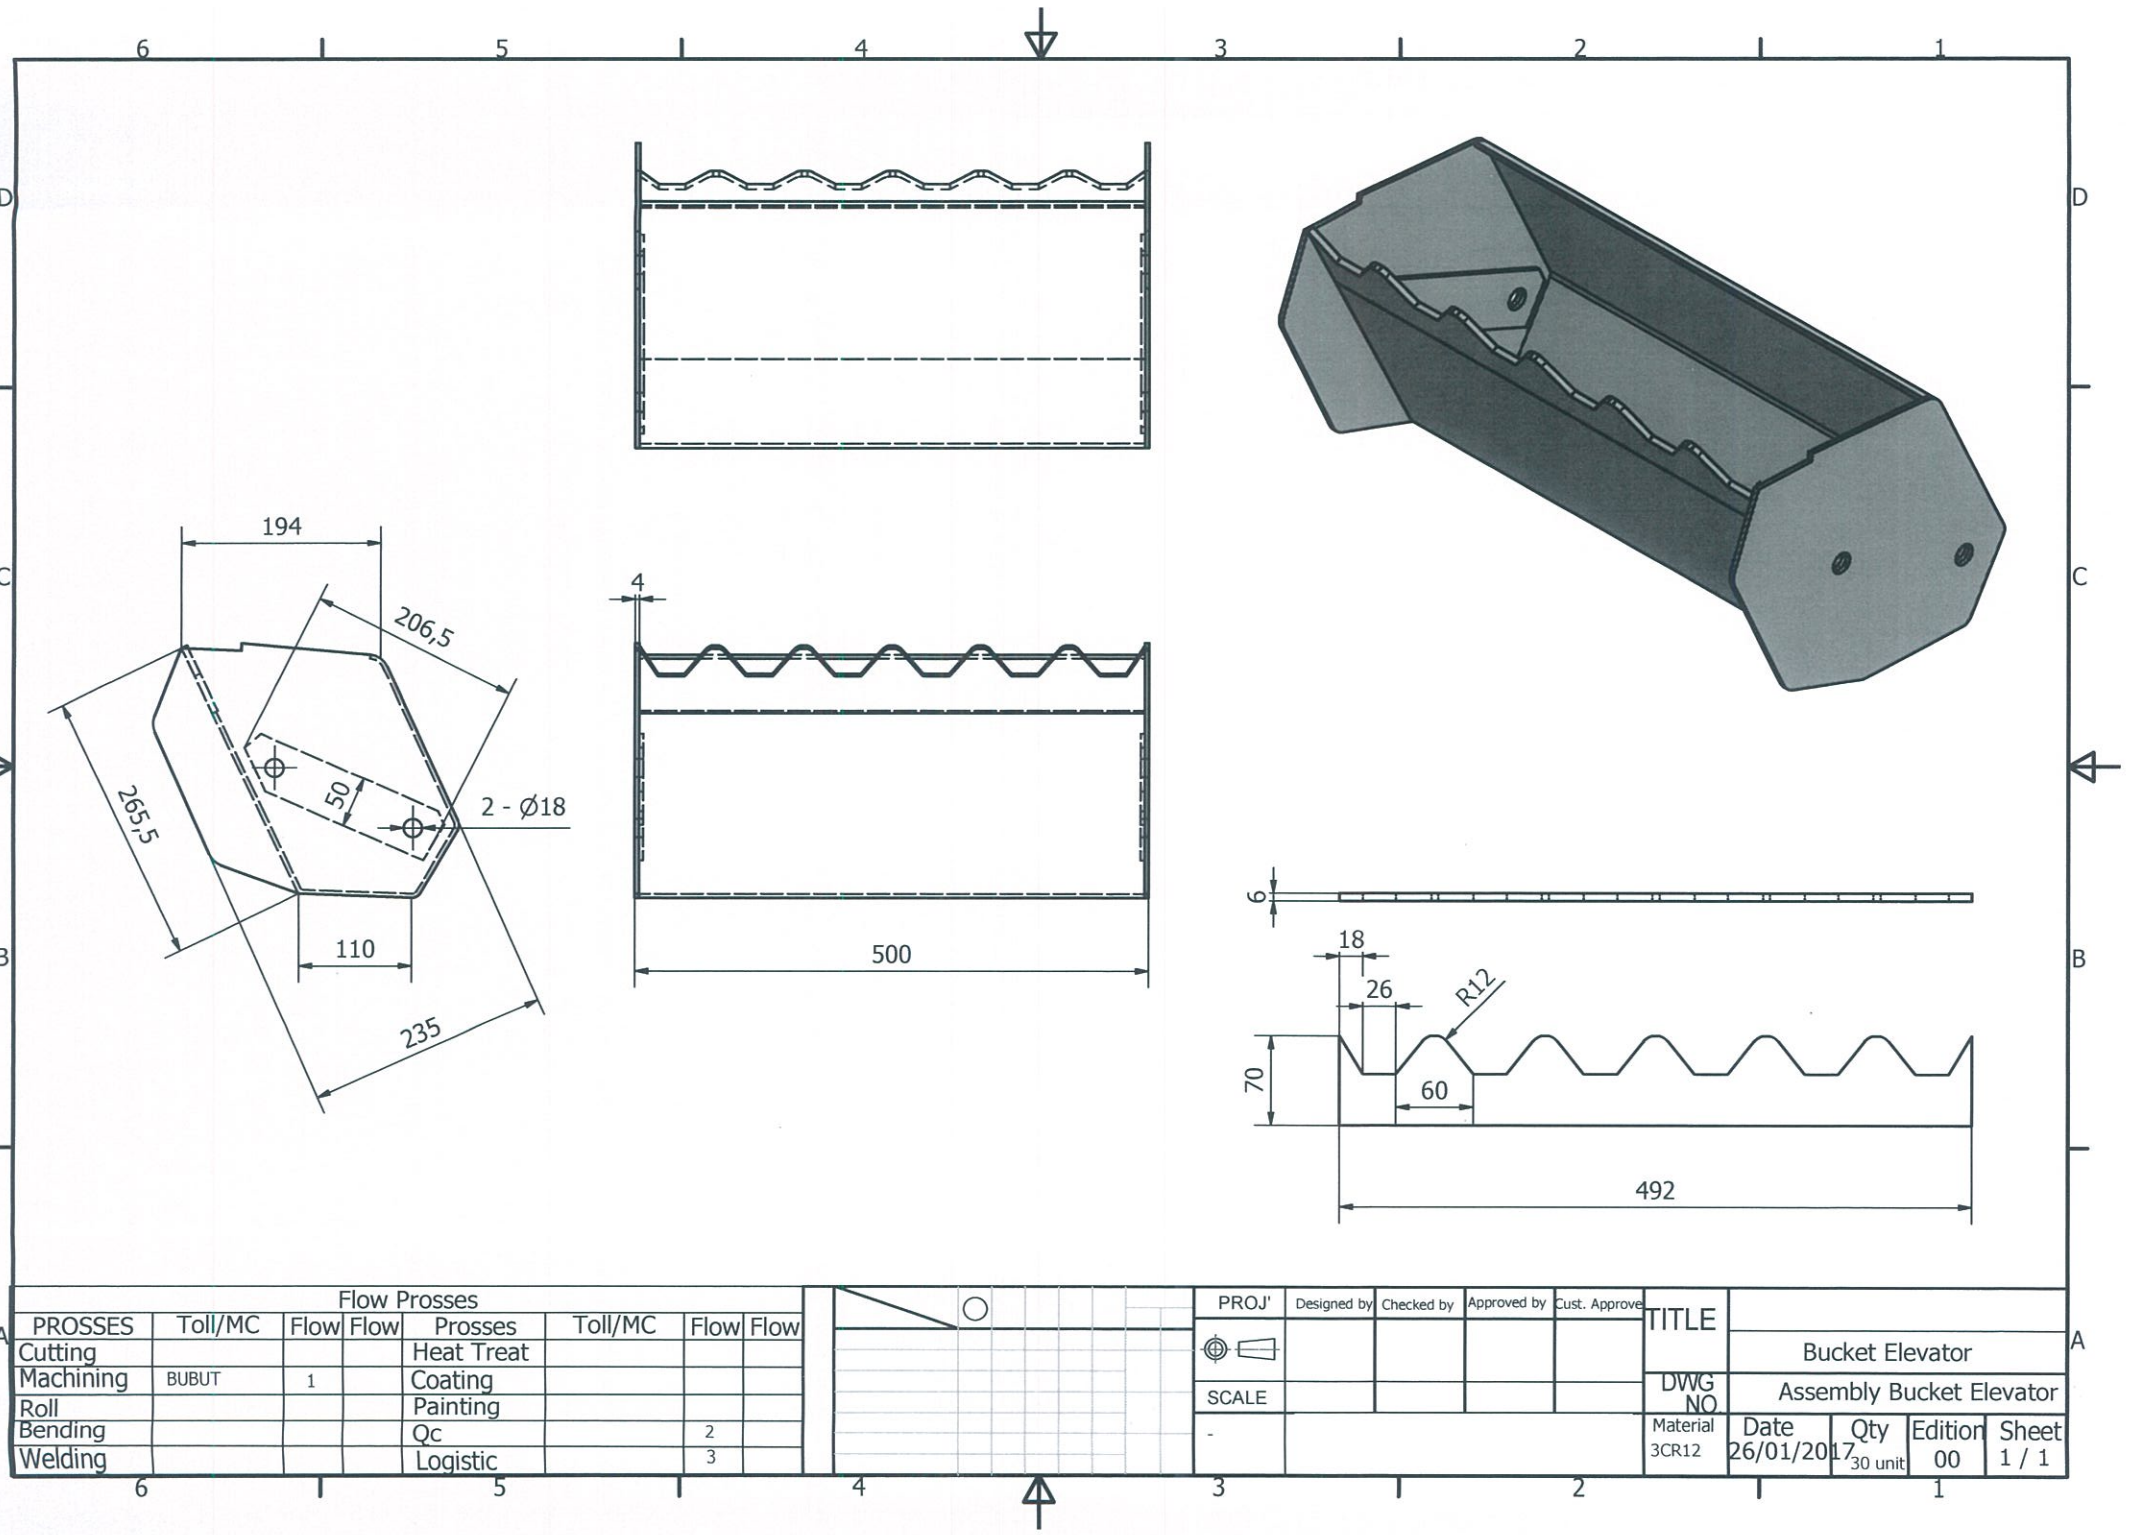

Flow Proses								PROJ'				TITLE			
PROSES	Toll/MC	Flow	Flow	Proses	Toll/MC	Flow	Flow	Designed by	Checked by	Approved by	Cust. Approve	Bucket Elevator			
Cutting				Heat Treat								Assembly Bucket Elevator			
Machining	BUBUT	1		Coating								DWG NO			
Roll				Painting								Material			
Bending				Qc		2						Date			
Welding				Logistic		3						26/01/2017			
												Qty			
												30 unit			
												Edition			
												00			
												Sheet			
												1 / 1			

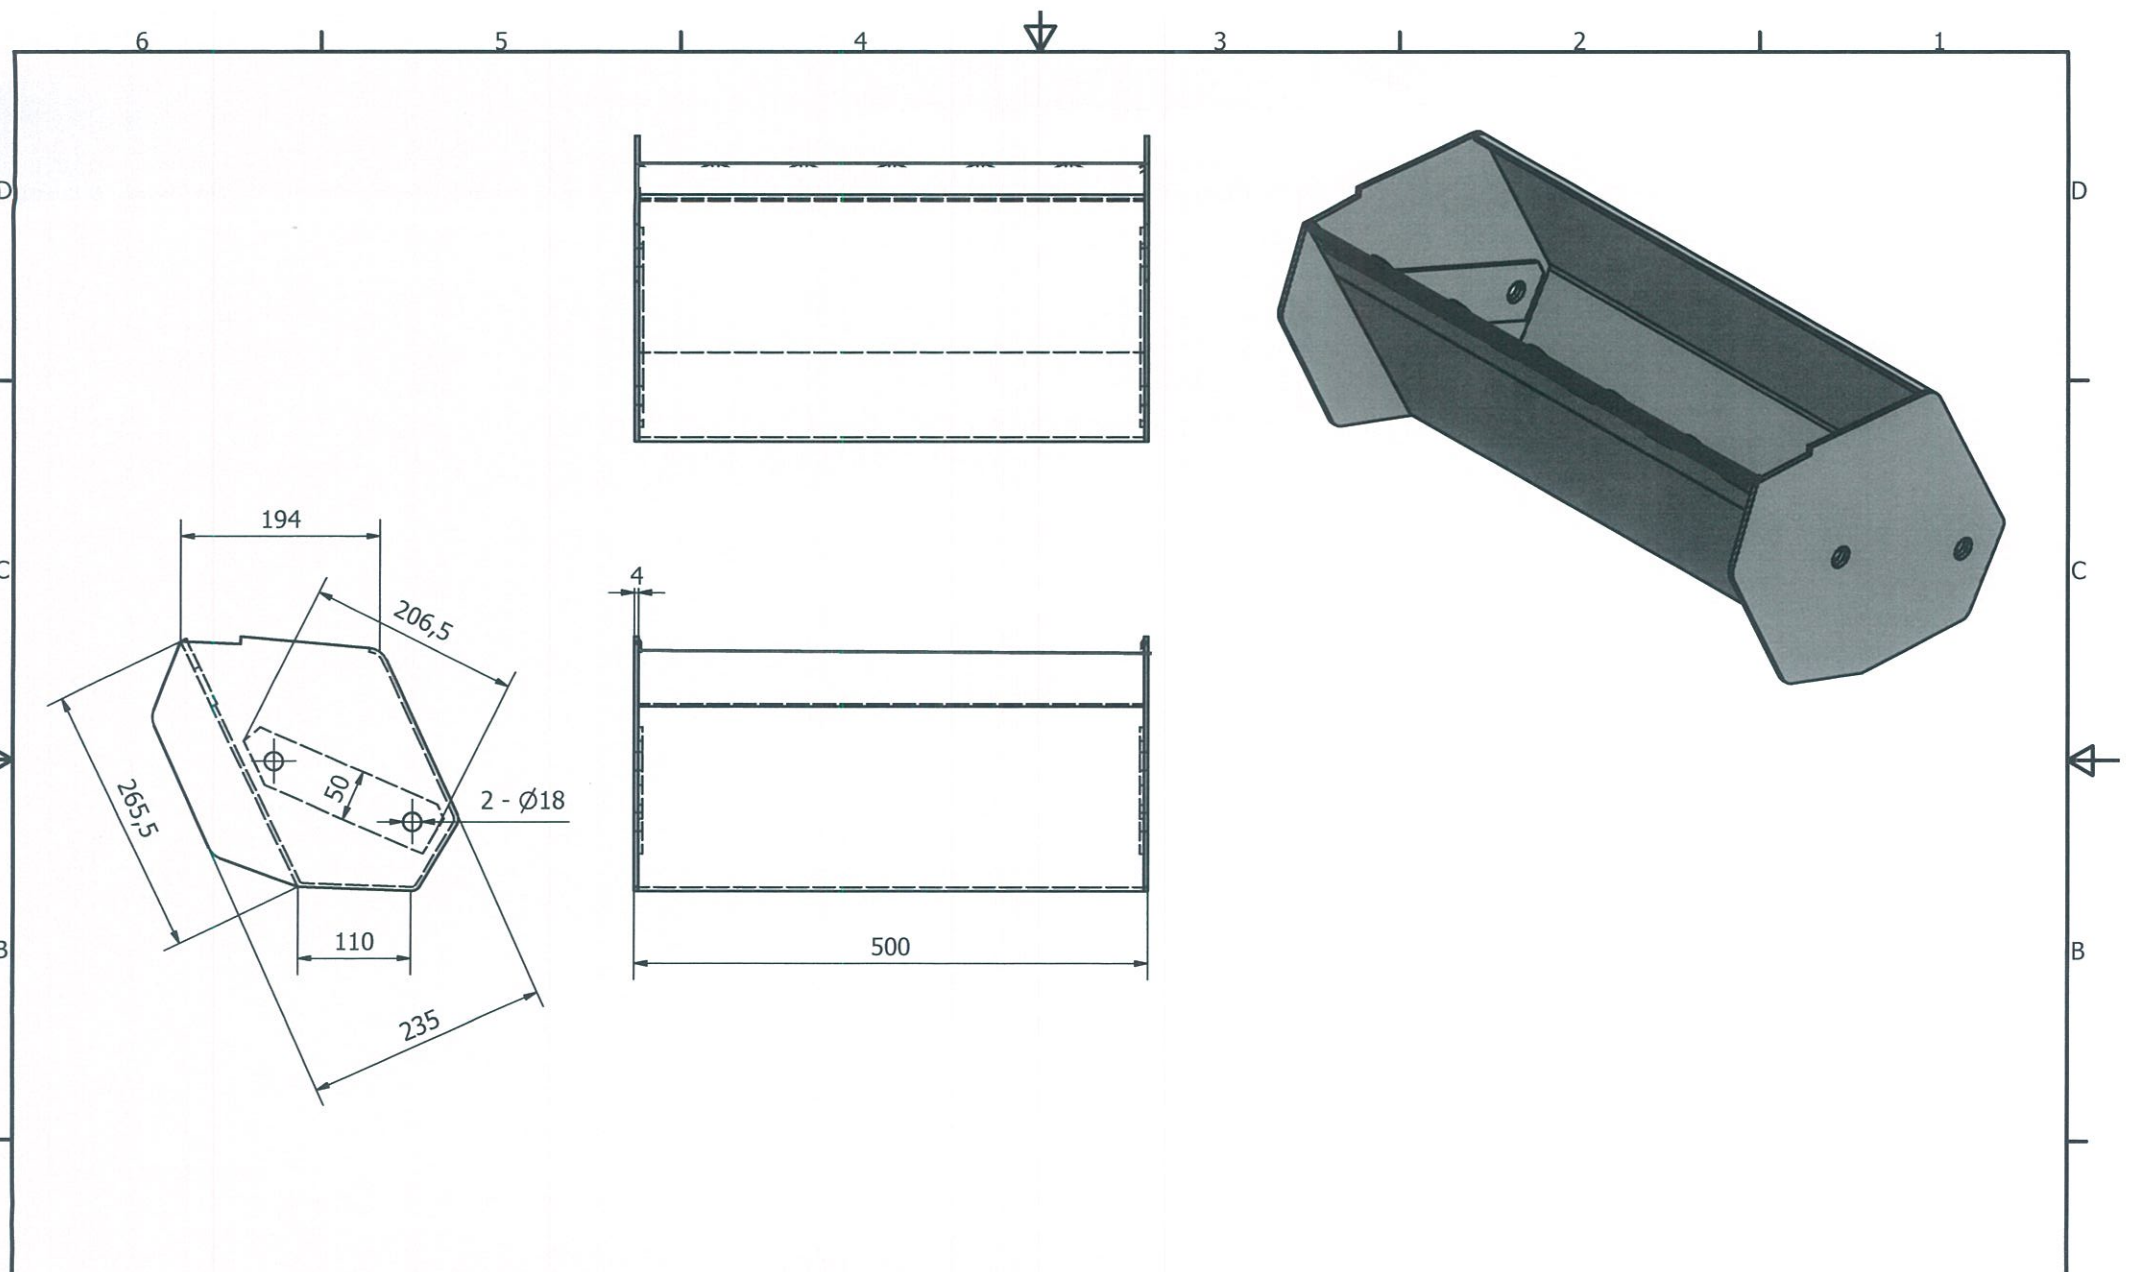

Flow Proses													PROJ'					Designed by					Checked by					Approved by					Cust. Approve					TITLE																																																																																																																																																																																																																	
PROSES	Toll/MC	Flow	Flow	Proses	Toll/MC	Flow	Flow																																																																																																																																																																																																																																																
Cutting				Heat Treat																																																																																																																																																																																																																																																			
Machining	BUBUT	1		Coating																																																																																																																																																																																																																																																			
Roll				Painting																																																																																																																																																																																																																																																			
Bending				Qc		2																																																																																																																																																																																																																																																	
Welding				Logistic		3																																																																																																																																																																																																																																																	
6								1								5								4								3								2								1								A																																																																																																																																																																																															

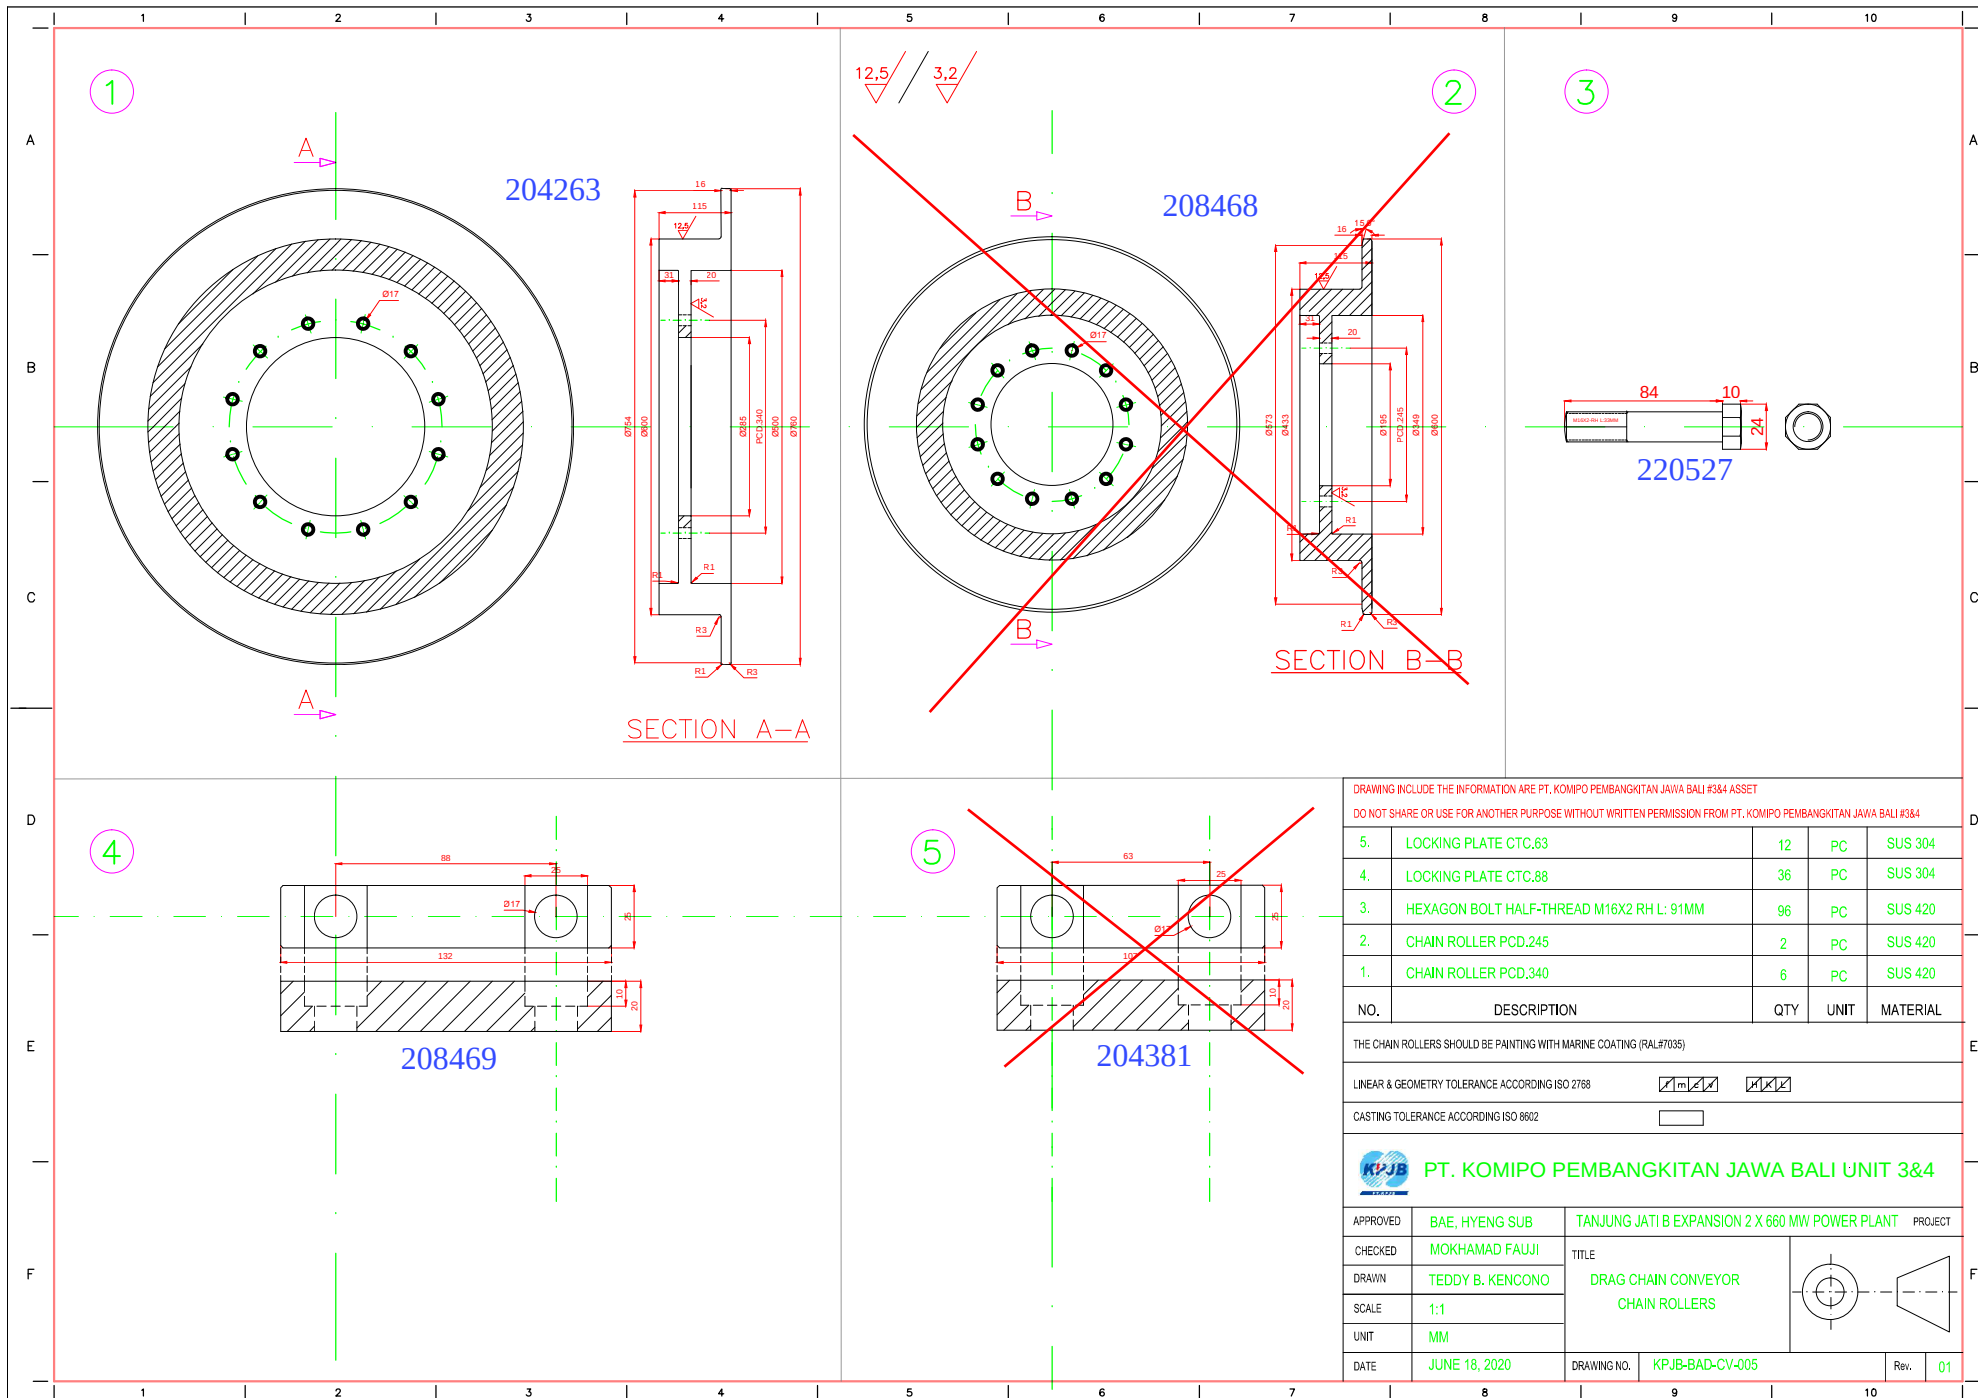

DRAWING INCLUDE THE INFORMATION ARE PT. KOMIPO PEMBANGKITAN JAWA BALI #3&4 ASSET
DO NOT SHARE OR USE FOR ANOTHER PURPOSE WITHOUT WRITTEN PERMISSION FROM PT. KOMIPO PEMBANGKITAN JAWA BALI #3&4

5.	LOCKING PLATE CTC.63	12	PC	SUS 304
4.	LOCKING PLATE CTC.88	36	PC	SUS 304
3.	HEXAGON BOLT HALF-THREAD M16X2 RH L: 91MM	96	PC	SUS 420
2.	CHAIN ROLLER PCD.245	2	PC	SUS 420
1.	CHAIN ROLLER PCD.340	6	PC	SUS 420

NO.	DESCRIPTION	QTY	UNIT	MATERIAL
THE CHAIN ROLLERS SHOULD BE PAINTING WITH MARINE COATING (RAL#7035)				
LINEAR & GEOMETRY TOLERANCE ACCORDING ISO 2768		M L K		
CASTING TOLERANCE ACCORDING ISO 8002		□		

KPIB PT. KOMIPO PEMBANGKITAN JAWA BALI UNIT 3&4

APPROVED	BAE, HYENG SUB	TANJUNG JATI B EXPANSION 2 X 660 MW POWER PLANT PROJECT	
CHECKED	MOKHAMAD FAUJI	TITLE	
DRAWN	TEDDY B. KENCONO	DRAG CHAIN CONVEYOR CHAIN ROLLERS	
SCALE	1:1		
UNIT	MM		
DATE	JUNE 18, 2020	DRAWING NO.	KPIB-BAD-CV-005
		Rev.	01

